



Republic of the Philippines
City of Tagbilaran
City Hall, Tagbilaran City, 6300 Bohol

REQUEST FOR QUOTATION
Procurement of INFRA
[Renovation of Tagbilaran City Central Public Market Toilet]

The City Government of Tagbilaran, through the Appropriation Ordinance No. 17-08 for FY 2018, intends to apply the sum of Six Hundred Seventy One Thousand Seven Hundred Nineteen Pesos and Twenty Three Centavos (Php671,719.23) being the Approved Budget for the Contract (ABC) to payments under the contract for Quotation No. 1811-432. Quotations from suppliers received in excess of the ABC shall be automatically rejected.

The City Government of Tagbilaran now invites suppliers to quote for **1 lot Renovation of Tagbilaran City Central Public Market (see attached plan)** for the **Eco. Ent., Tagbilaran City**. Work may commence not later than **7 Calendar Days** from receipt of Notice to Proceed to Complete is within **60 Calendar Days**. Contractors should have completed, within 24 months from the date of submission and receipt of quotations, a contract similar to the Project. The description of an eligible supplier is contained in the Bidding Documents, particularly, in Section 11, Instruction to Bidders.

Quotation for INFRA will be conducted through open competitive procedures as specified in the Implementing Rules and Regulations (IRR) of Republic Act (RA) 9184, otherwise known as the "Government Procurement Reform Act".

Quotation for the INFRA is open to all interested contractors, whether local or foreign, subject to the conditions for eligibility provided in the IRR of RA 9184.

Interested contractors may obtain further information from the City Government of Tagbilaran at the address given below during 8:00 AM - 5:00 PM Monday to Friday only except holidays.

A set of Request for Quotation be purchased by interested Contractors on November 21 - 28, 2018 from the address below and upon payment of a non-refundable fee in the amount of **P150.00**.

Quotations must be delivered to the address below on or before November 28, 2018 at 5:00 PM.

Request for Quotations will be opened and the lowest quotation for the infra will be awarded the supply of the infra to be procured at the BAC Office, CEO, Tagbilaran City. Late quotations shall not be accepted.

The City Government of Tagbilaran reserves the right to accept or reject any quotations, to annul the awarding process and to reject all quotations at any time prior to contract award, without thereby incurring any liability to the affected suppliers.


CATHELYN O. TORREMOCHA
BAC Chairman

Company Name: _____
 Address : _____

REQUEST FOR QUOTATION

Please quote your lowest price on the item/s listed below, subject to the General Conditions on the last page, stating the shortest time of delivery and submit your quotation duly signed by your representative not later than **November 28, 2018 at 5:00PM**.



CATHELYN O. TORREMOCHA
 Procurement Officer

- NOTE: 1 ALL ENTRIES MUST BE TYPEWRITTEN IF POSSIBLE
- 2 QUOTATIONS WITH ERASURES WILL BE DULY INITIALLED
- 3 WORK MAY COMMENCE NOT LATER THAN 7 CALENDAR DAYS FROM RECEIPT OF P.O.
 CALENDAR DAYS TO COMPLETE IS **60 Calendar Days**.
- 4 WARRANTY OF THE PROJECT MUST CONFORM AS REQUIRED PER REVISED IRR SEC. 62.2 OF R.A. 9184
- 5 PRICE VALIDITY SHALL BE FOR A PERIOD OF **100 CALENDAR DAYS**
- 6 **PCAB LICENSE, OMNIBUS STATEMENT, VALID MAYOR'S PERMIT, BIR CERTIFICATE OF REGISTRATION, CURRENT INCOME TAX RETURN AND VALID PHILGEPS REGISTRATION CERTIFICATE (Platinum) SHALL BE ATTACHED UPON SUBMISSION OF THE QUOTATION**
- 7 SUBJECT TO SUBMISSION OF LEGAL DOCUMENTS FOR THE DETERMINATION OF TECHNICAL, LEGAL, AND FINANCIAL CAPABILITY OF SUPPLIER
- 8 SUBJECT TO REVIEW BY THE COMMISSION ON AUDIT AND IF EVER FOUND TO BE OVERPRICED, YOU ARE BOUND TO REFUND THE AMOUNT SAID TO BE EXCESSIVE.

ITEM NO.	ITEM AND DESCRIPTION	BRAND	QTY	UNIT	UNIT Price	TOTAL COST
1	Renovation of Tagbilaran City Central Public Market		1	lot		
	ITEM I - Dismantling/Demolition - 98.50 sq.m.					
	ITEM II - Floor Leveling / Topping (T - 40MM) - 42 sq.m.					
	ITEM III - Finishing Works - 1 lot					
	ITEM IV - Plumbing Fittings and Fixtures - 1 lot					
	ITEM V - Painting (Ceiling - 42.0 sqm, Wooden Painting - 8.4 sq.m) - 50.40 sq.m.					
	ITEM VI - Electrical Works (Lighting Fixture and Relocation Only) - 1 lot					
	****see attached plans****					
	XXXXXXXXXXXXXXXXXXXXXXXXXXXXXXXXXXXXXXXXXXXXXXXXXXXXXXXXXXXX					
	TOTAL					


Delivery Period : _____
 Warranty : _____
 Price Validity : _____


After having carefully read and accepted your General Condition, I/We quote you on the item at prices noted above.

 Signature Over Printed Name
 Tel. No. : _____
 Cell No. : _____
 Email Add. : _____
 Date : _____

REPUBLIC OF THE PHILIPPINES CITY OF TAGBILARAN CITY GOV'T OF TAGBILARAN OFFICE OF THE CITY ENGINEER		PROJECT TITLE: RENOVATION OF CENTRAL MARKET TOILET	PREPARED BY: ROMMEL B. MONTON DRAFTSMAN	CHECKED BY: RAUL ZAMORA ARCHITECT I	SUBMITTED/RECOMMENDED: TEODORO PRESTOQUE DIC-CBC	APPROVED: JOHN GEESNELL YAP II CITY ENGINEER	SHEET NO. 1 5
LOCATION: DAO DISTRICT TAGBILARAN CITY							


FLOOR PLAN
SCALE: 1:100 M

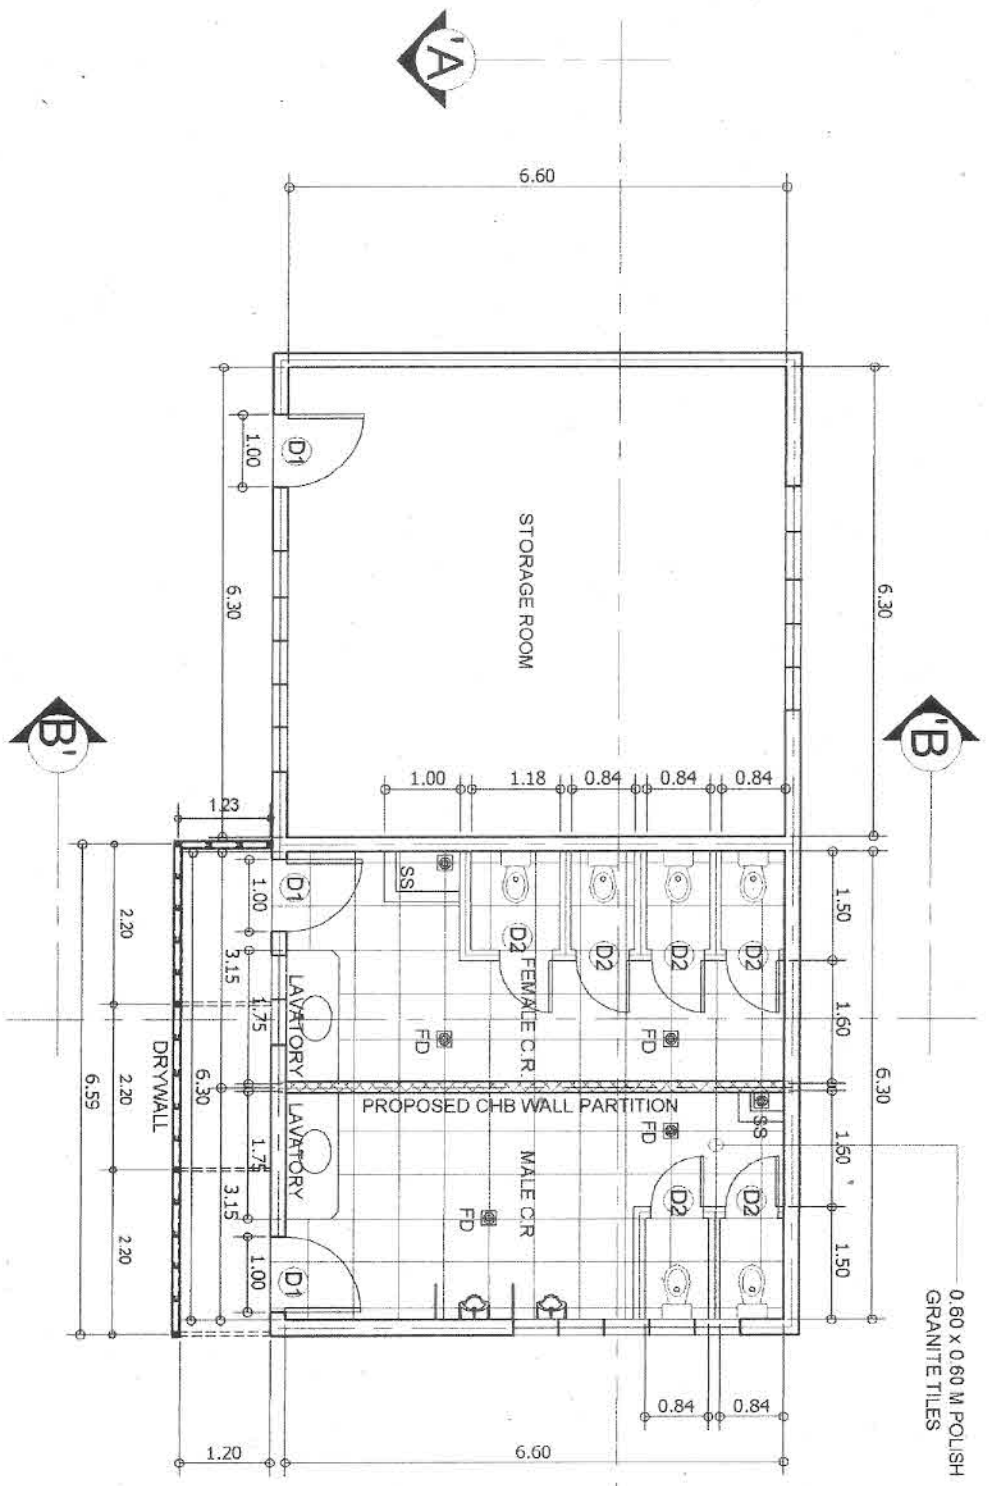

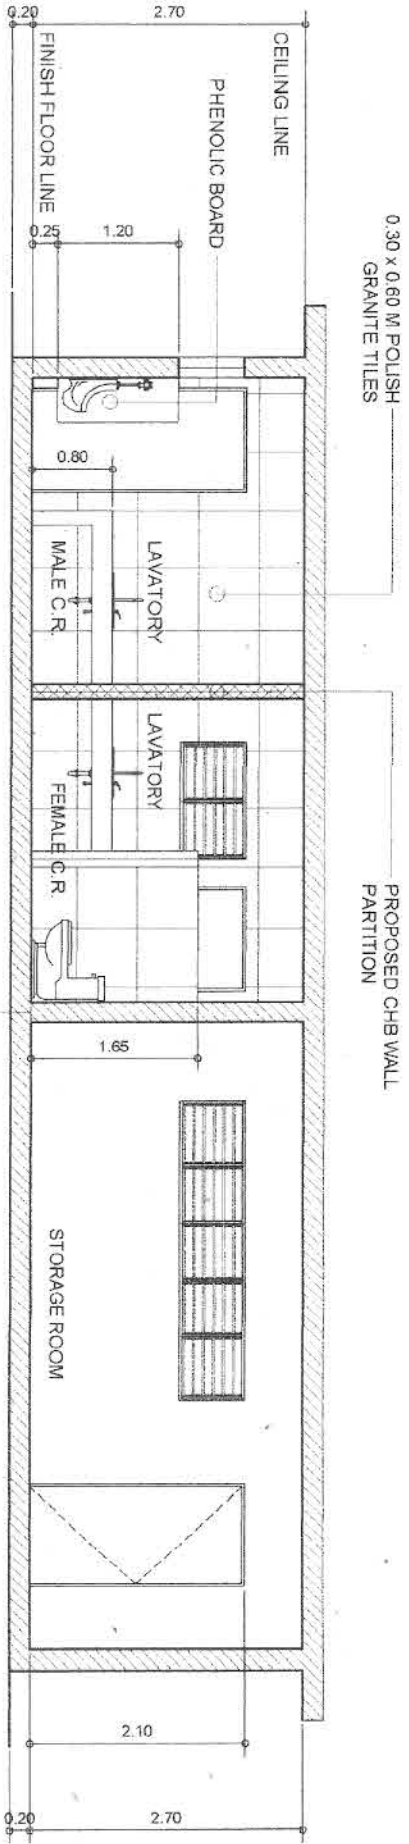

CROSS SECTION 'A-A'

SCALE: 1:75M

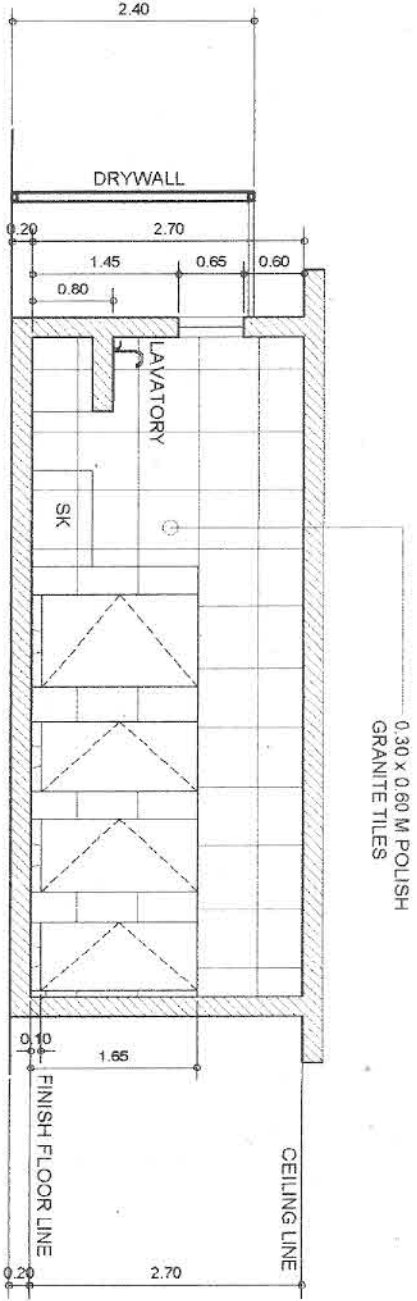

CROSS SECTION 'B-B'

SCALE: 1:75M

REPUBLIC OF THE PHILIPPINES
CITY OF TAGBILARAN
CITY GOVT OF TAGBILARAN
OFFICE OF THE CITY ENGINEER

PROJECT TITLE
**RENOVATION OF CENTRAL
MARKET TOILET**

LOCATION: DAO DISTRICT, TAGBILARAN CITY

PREPARED BY
Rommel B. Monton
ROMMEL B. MONTON
DRAFTSMAN


CHECKED BY
Raul Zamora Nomo
RAUL ZAMORA NOMO
ARCHITECT II

SUBMITTED/RECOMMENDED
Terborck P. Stoque
TERBORCK P. STOQUE
ARCHITECT

APPROVED
John Gersmell Yap II
JOHN GERSMELL YAP II
CITY MANOR





SHEET NO.
2
5

ELECTRICAL LAY-OUT PLAN
SCALE: 1/100


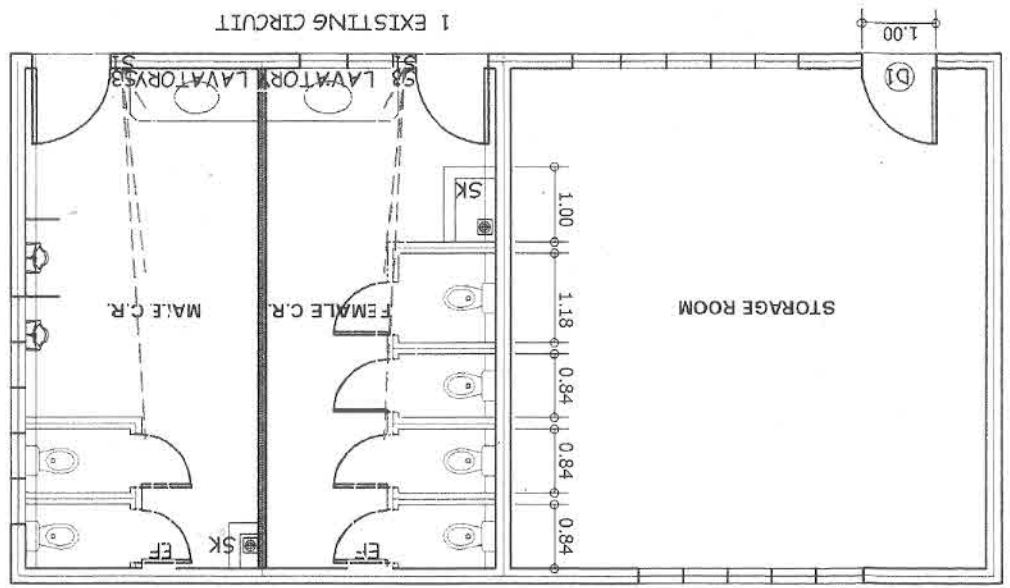


- LEGENDS:
- 18W LED LIGHT WITH FIXTURE
 - HOME RUN
 - CIRCUIT LINE
 - SWITCH LINE
 - EXHAUST FAN

GENERAL NOTES & SPECIFICATION:
 1. THIS PLAN AND THE INSTALLATION SHALL CONFORM TO THE LATEST EDITION OF THE PHILIPPINE ELECTRICAL CODE, AND EXISTING ORDINANCES OF THE LGU & DU CONCERN.
 2. SERVICE SHALL BE 2-WIRE, 230VAC & 60 HZ.
 3. A VOLTAGE DROP OF 2% WAS CONSIDERED IN THE PREPARATION OF THE PLAN.
 4. ALL MATERIALS SHALL BE BRAND NEW, OF QUALITY, AND THAT OF THE APPROVE TYPE OF USE & LOCATION.
 5. THE INSTALLATION SHALL BE UNDER THE DIRECT SUPERVISION OF A QUALIFIED ELECTRICAL PRACTITIONER.

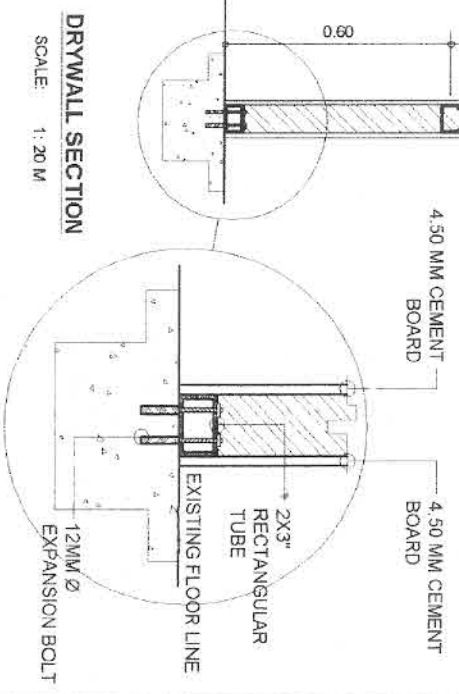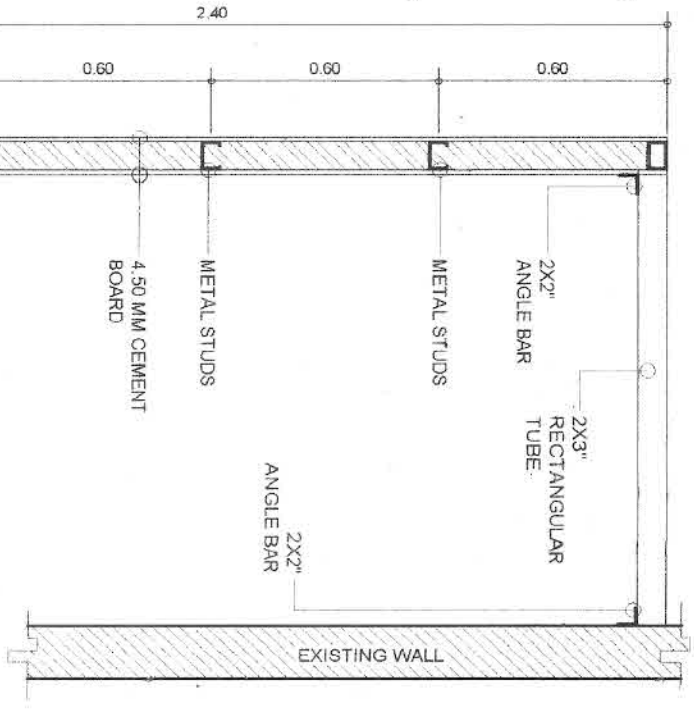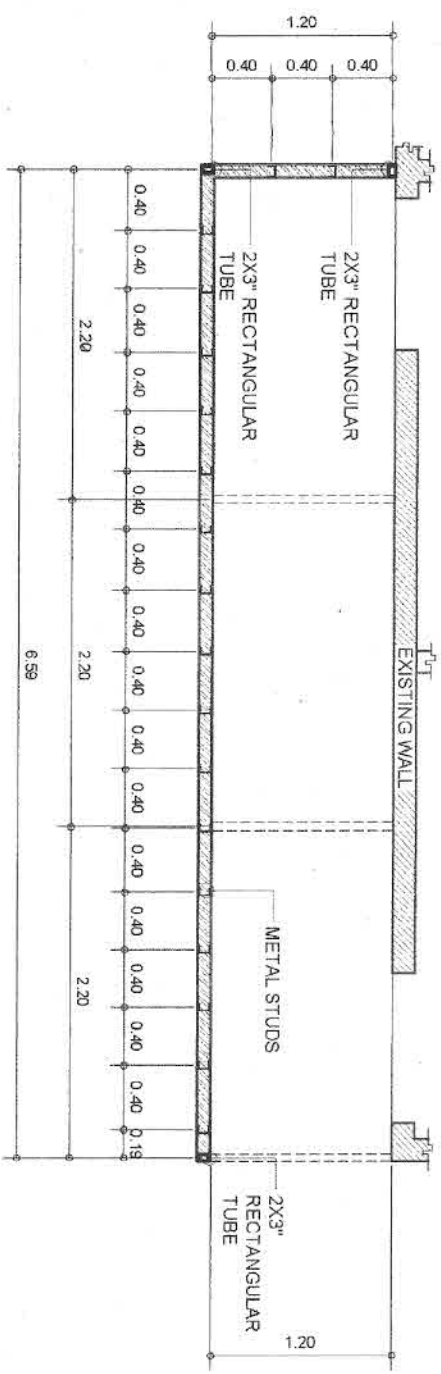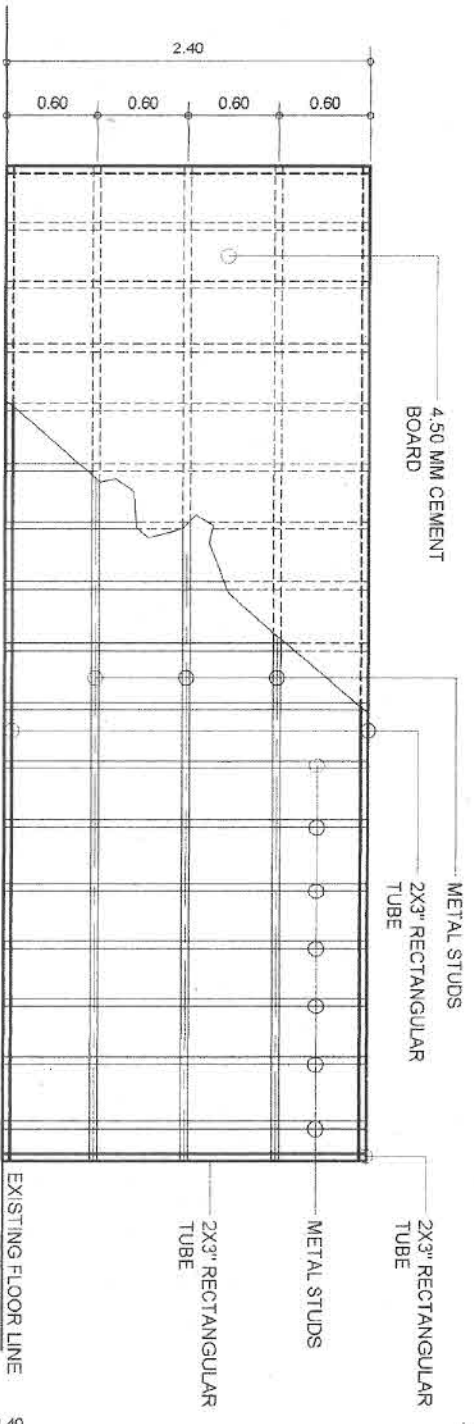

REPUBLIC OF THE PHILIPPINES CITY OF TAGBILARAN		PROJECT TITLE RENOVATION OF CENTRAL MARKET TOILET		PREPARED BY: ROMMEL B. MONTON <small>DRAFTSMAN</small>		CHECKED BY: RAUL ZAMORA <small>ARCHITECT II</small>		SUBMITTED/RECOMMENDED BY: TEODORO T. ESTOQUE <small>OIC-CF</small>		APPROVED: JOHN GEESMILL L. VAP II <small>CITY MANOR</small>		SHEET NO 3 4	
CITY GOVT OF TAGBILARAN OFFICE OF THE CITY ENGINEER				LOCATION: <small>DAS DISTRICT TAGBILARAN CITY</small>									

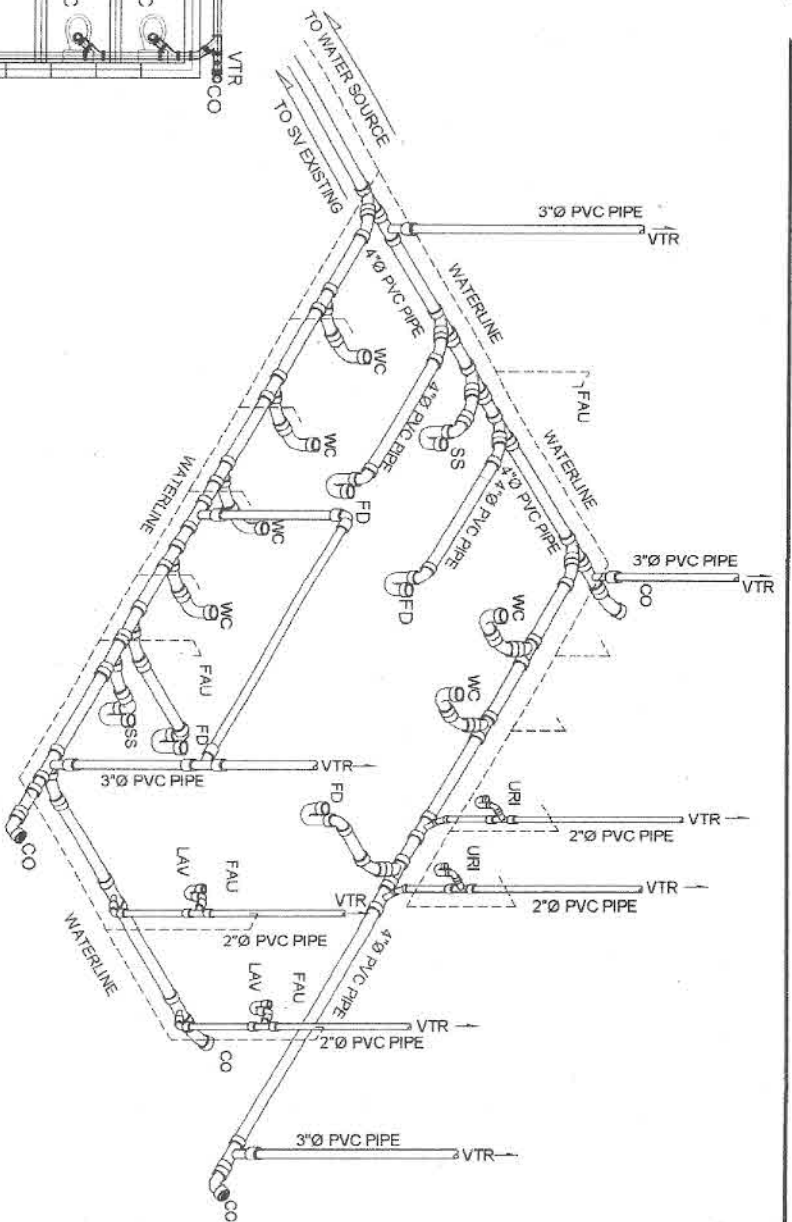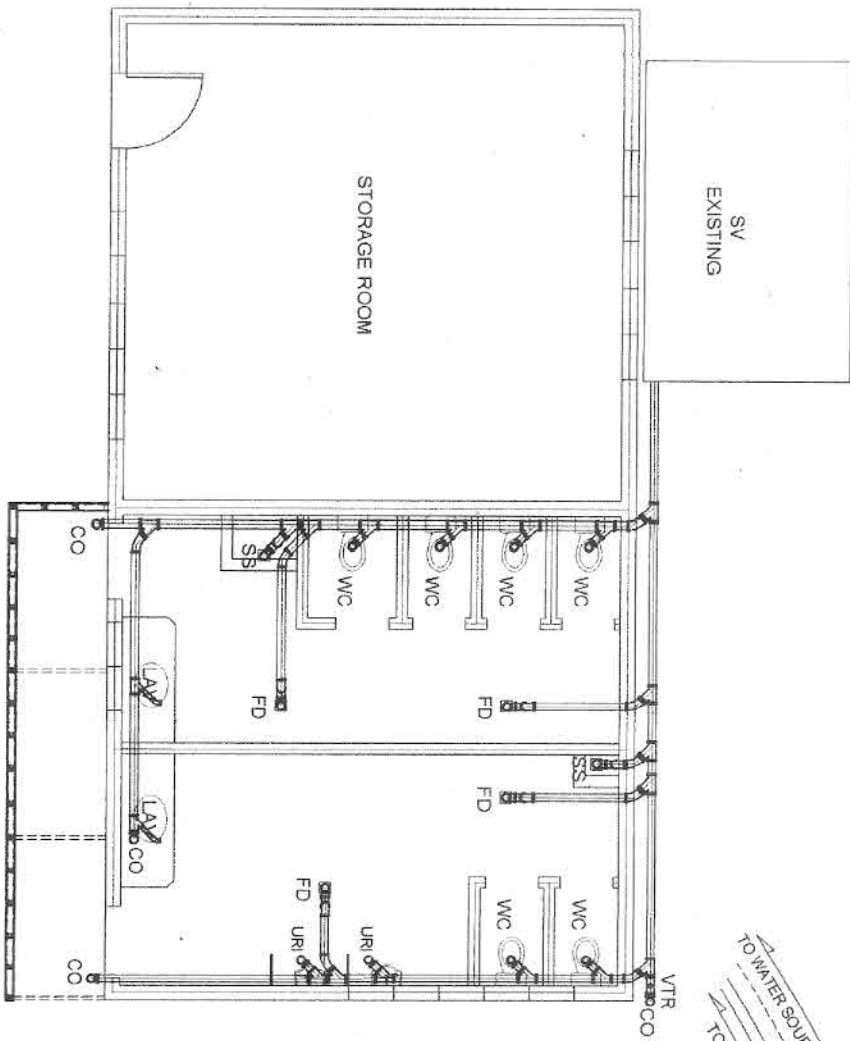

REPUBLIC OF THE PHILIPPINES
CITY OF TAGBILARAN
CITY GOV'T OF TAGBILARAN
OFFICE OF THE CITY ENGINEER

PROJECT TITLE:
RENOVATION OF CENTRAL
MARKET TOILET

LOCATION:
DAO DISTRICT TAGBILARAN CITY

PREPARED BY:
ROMMEL B. MONTON
DRAFTSMAN

CHECKED BY:
BALILI ZAMORA ROMO
ARCHITECT

SUBMITTED/RECOMMENDED:
TEODORO ESPINOSE
DICTOR

APPROVED:
JOHN GESSMELT
DRAFTSMAN

SHEET NO.
5